





ATTACHMENT B

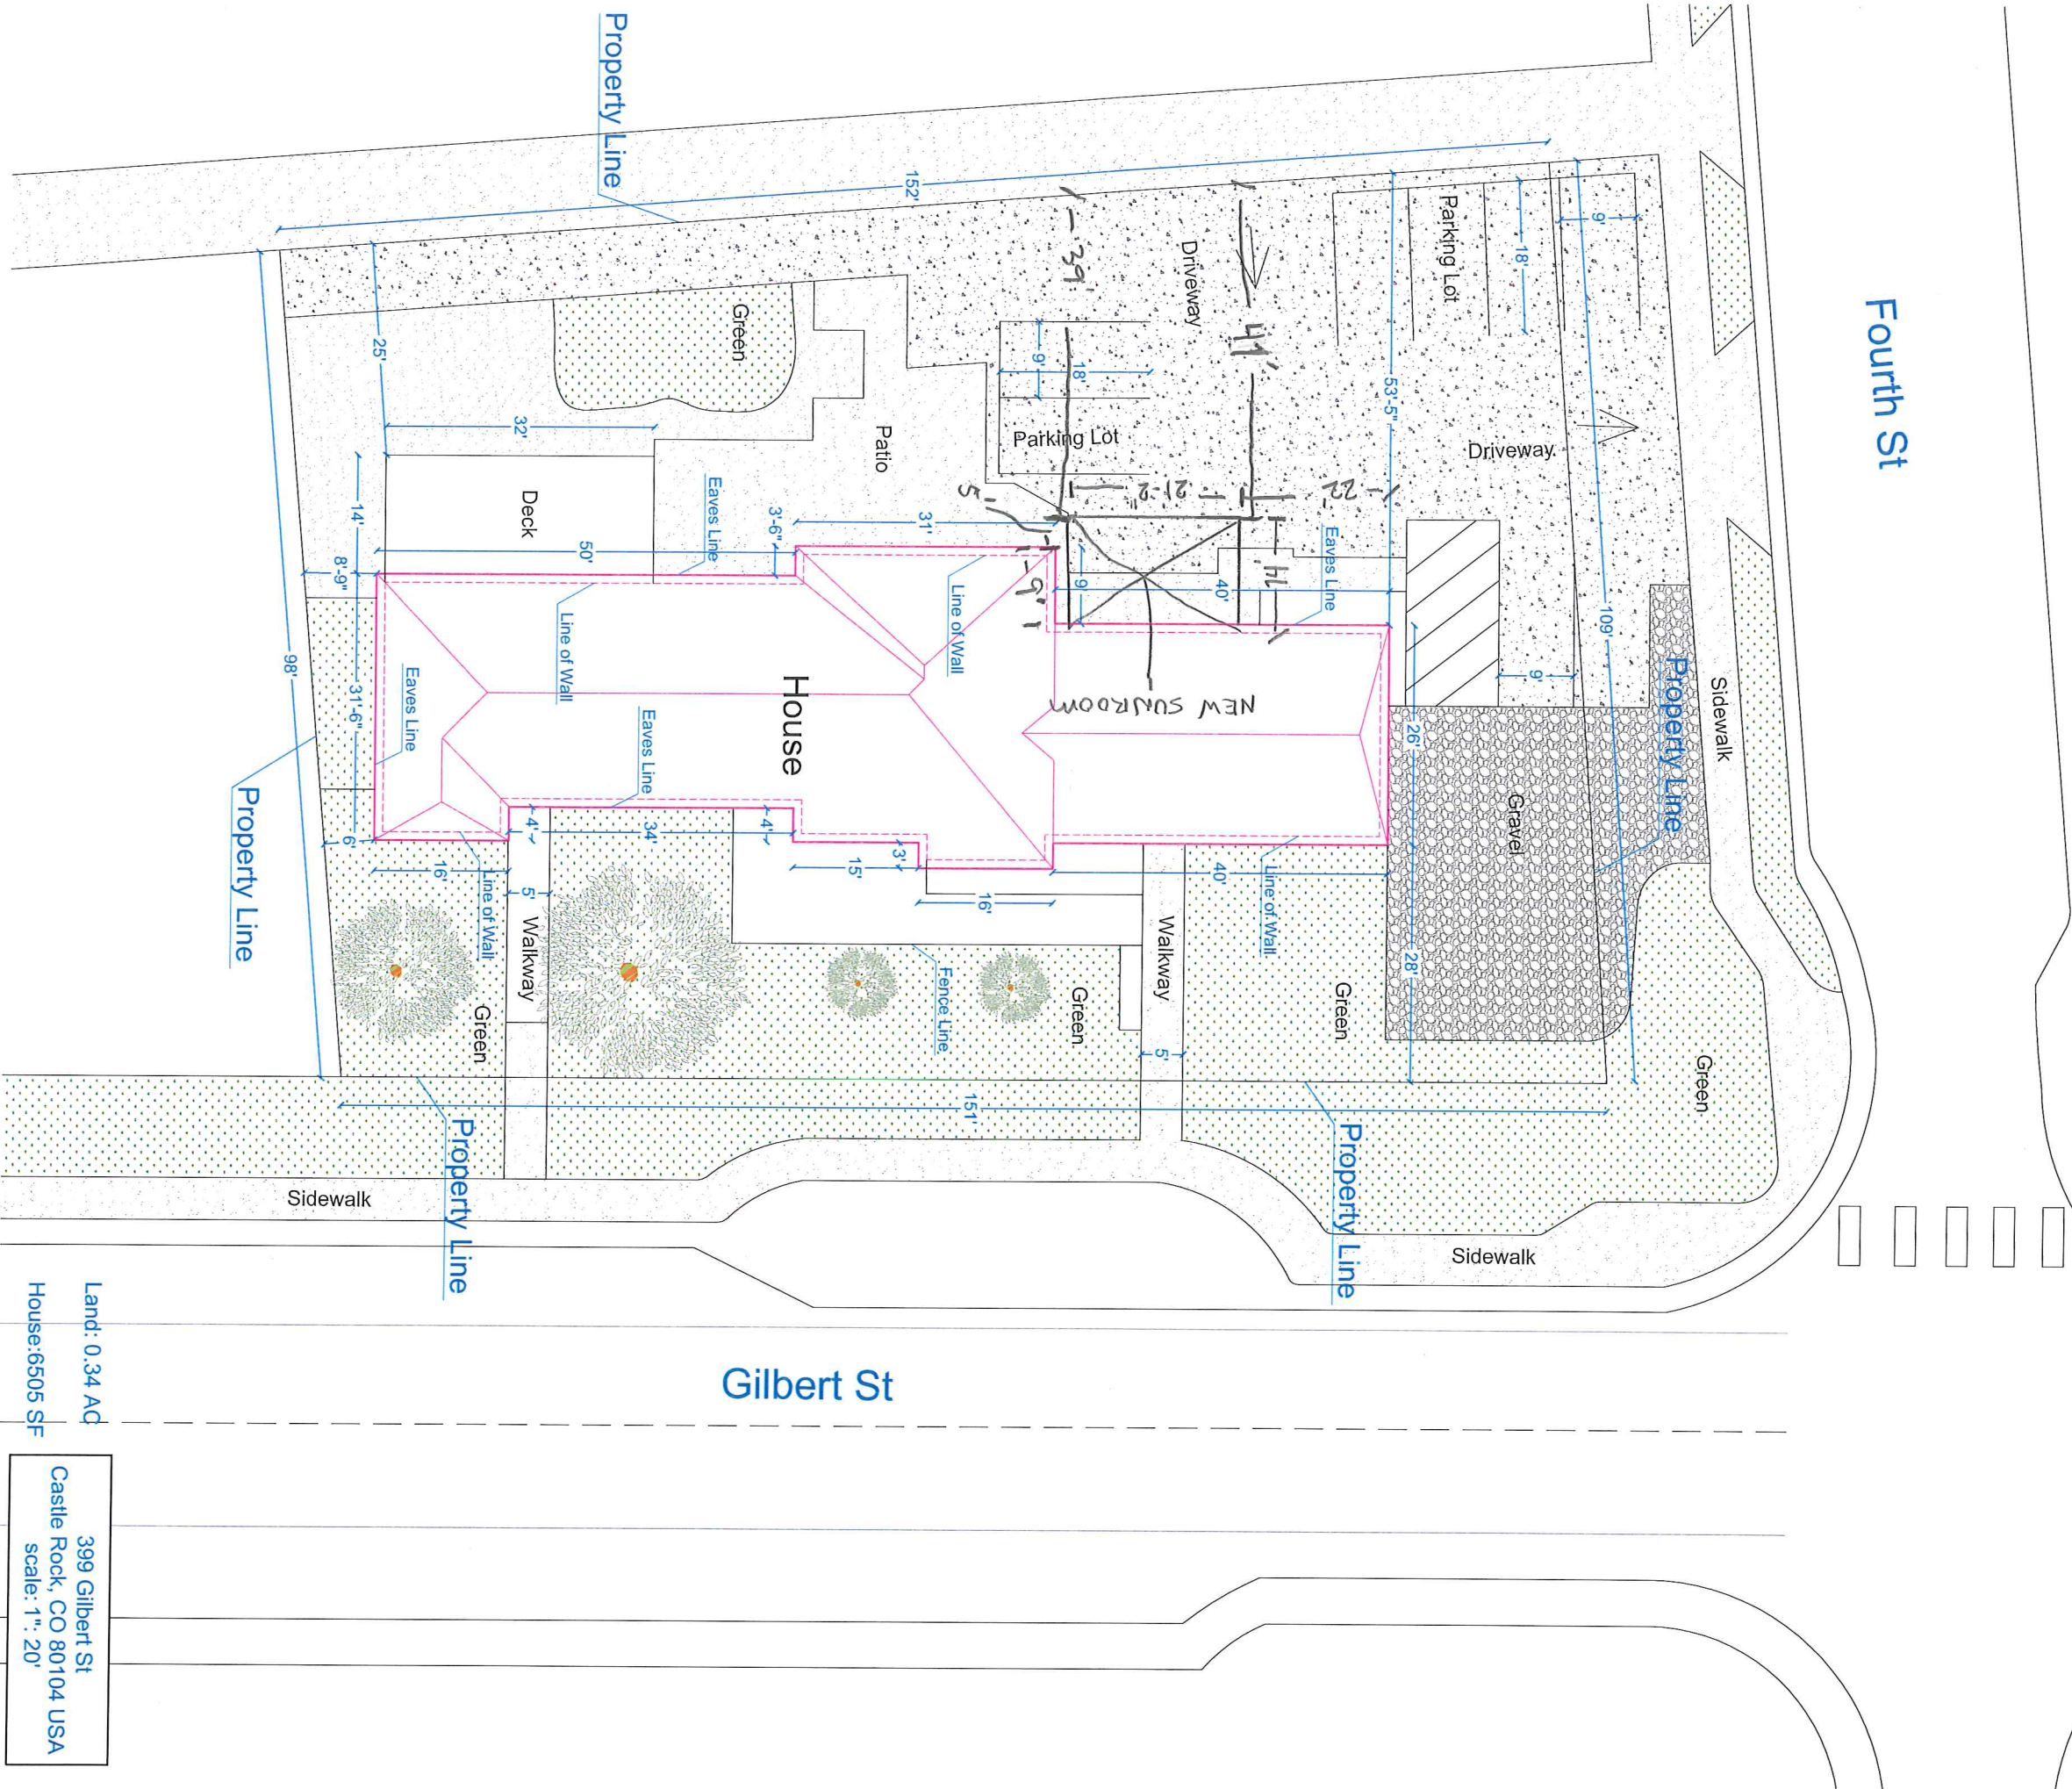


Land: 0.34 AC  
House: 6505 SF  
399 Gilbert St  
Castle Rock, CO 80104 USA  
Scale: 1" = 20'




COPYRIGHT 2018 ROBERT C. WACKER. ALL RIGHTS RESERVED. THE PLANS, DRAWINGS, ELEVATIONS, ILLUSTRATIONS, AND OTHER MATERIALS CONTAINED ON THESE PAGES ARE THE SOLE PROPERTY OF ROBERT C. WACKER AND SHALL NOT BE REPRODUCED IN WHOLE OR IN PART WITHOUT THE EXPRESS WRITTEN PERMISSION OF ROBERT C. WACKER.

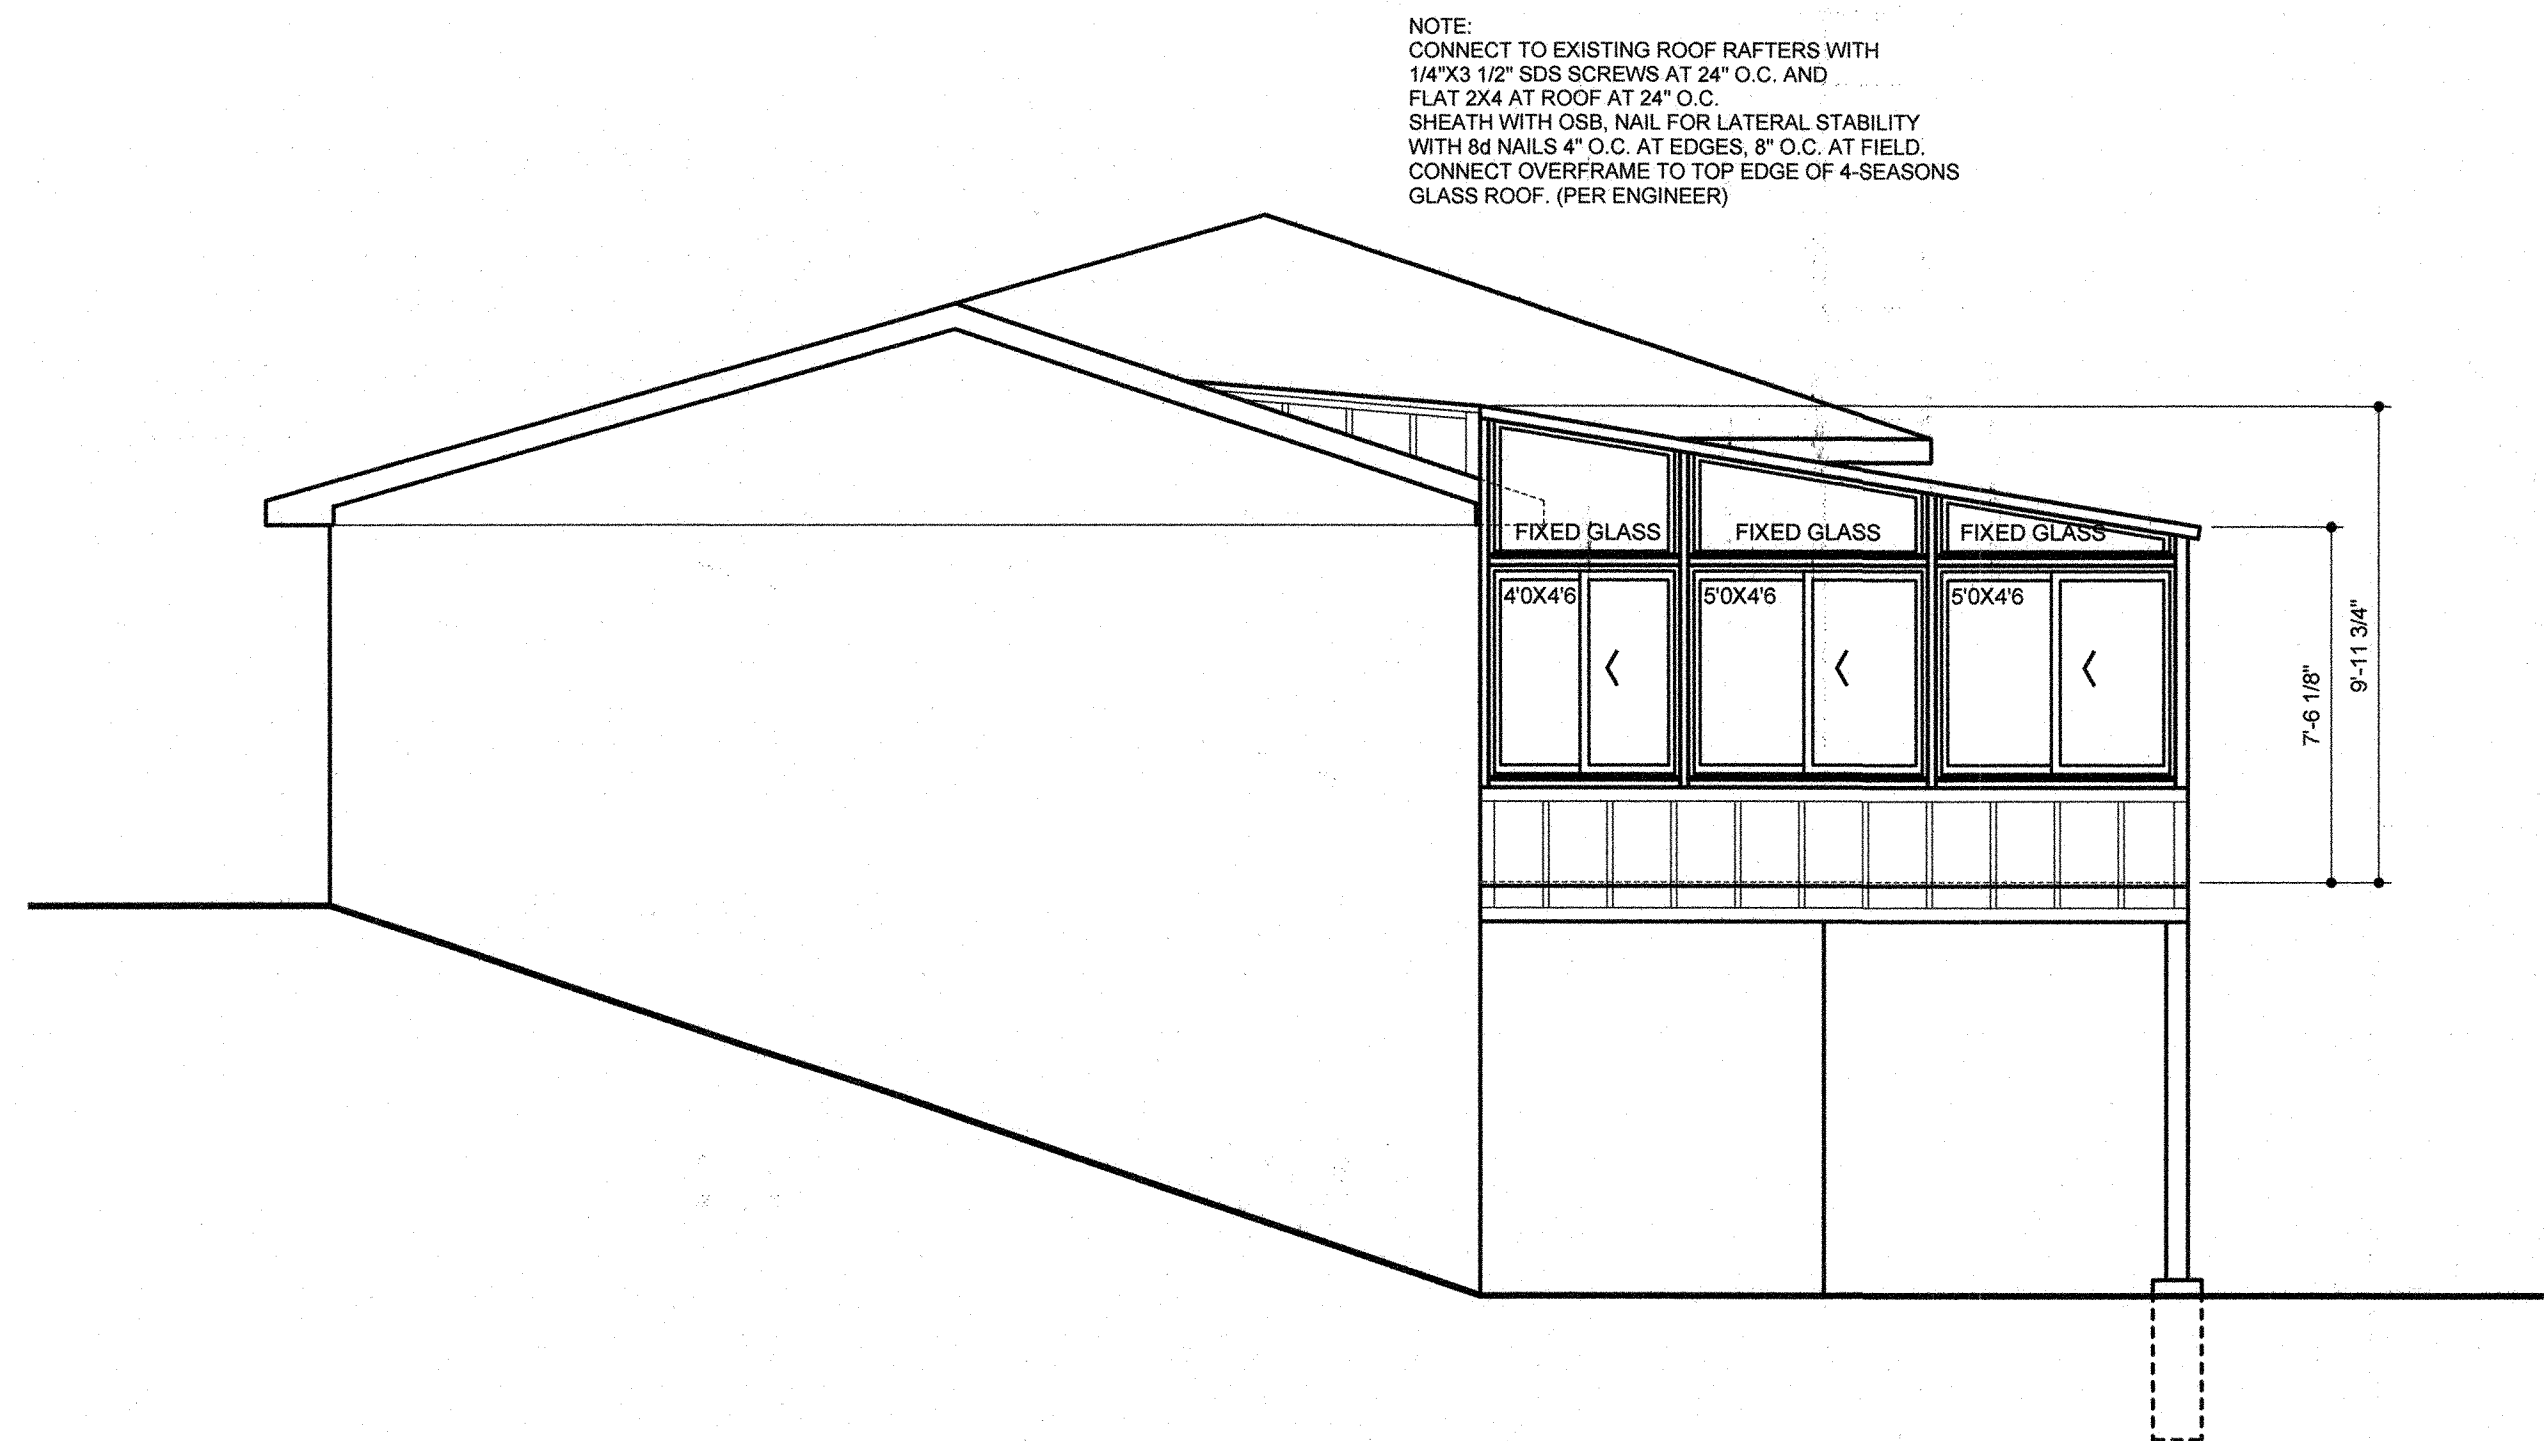

2 left & right side elevations  
A2 scale 1/4" = 1' - 0"

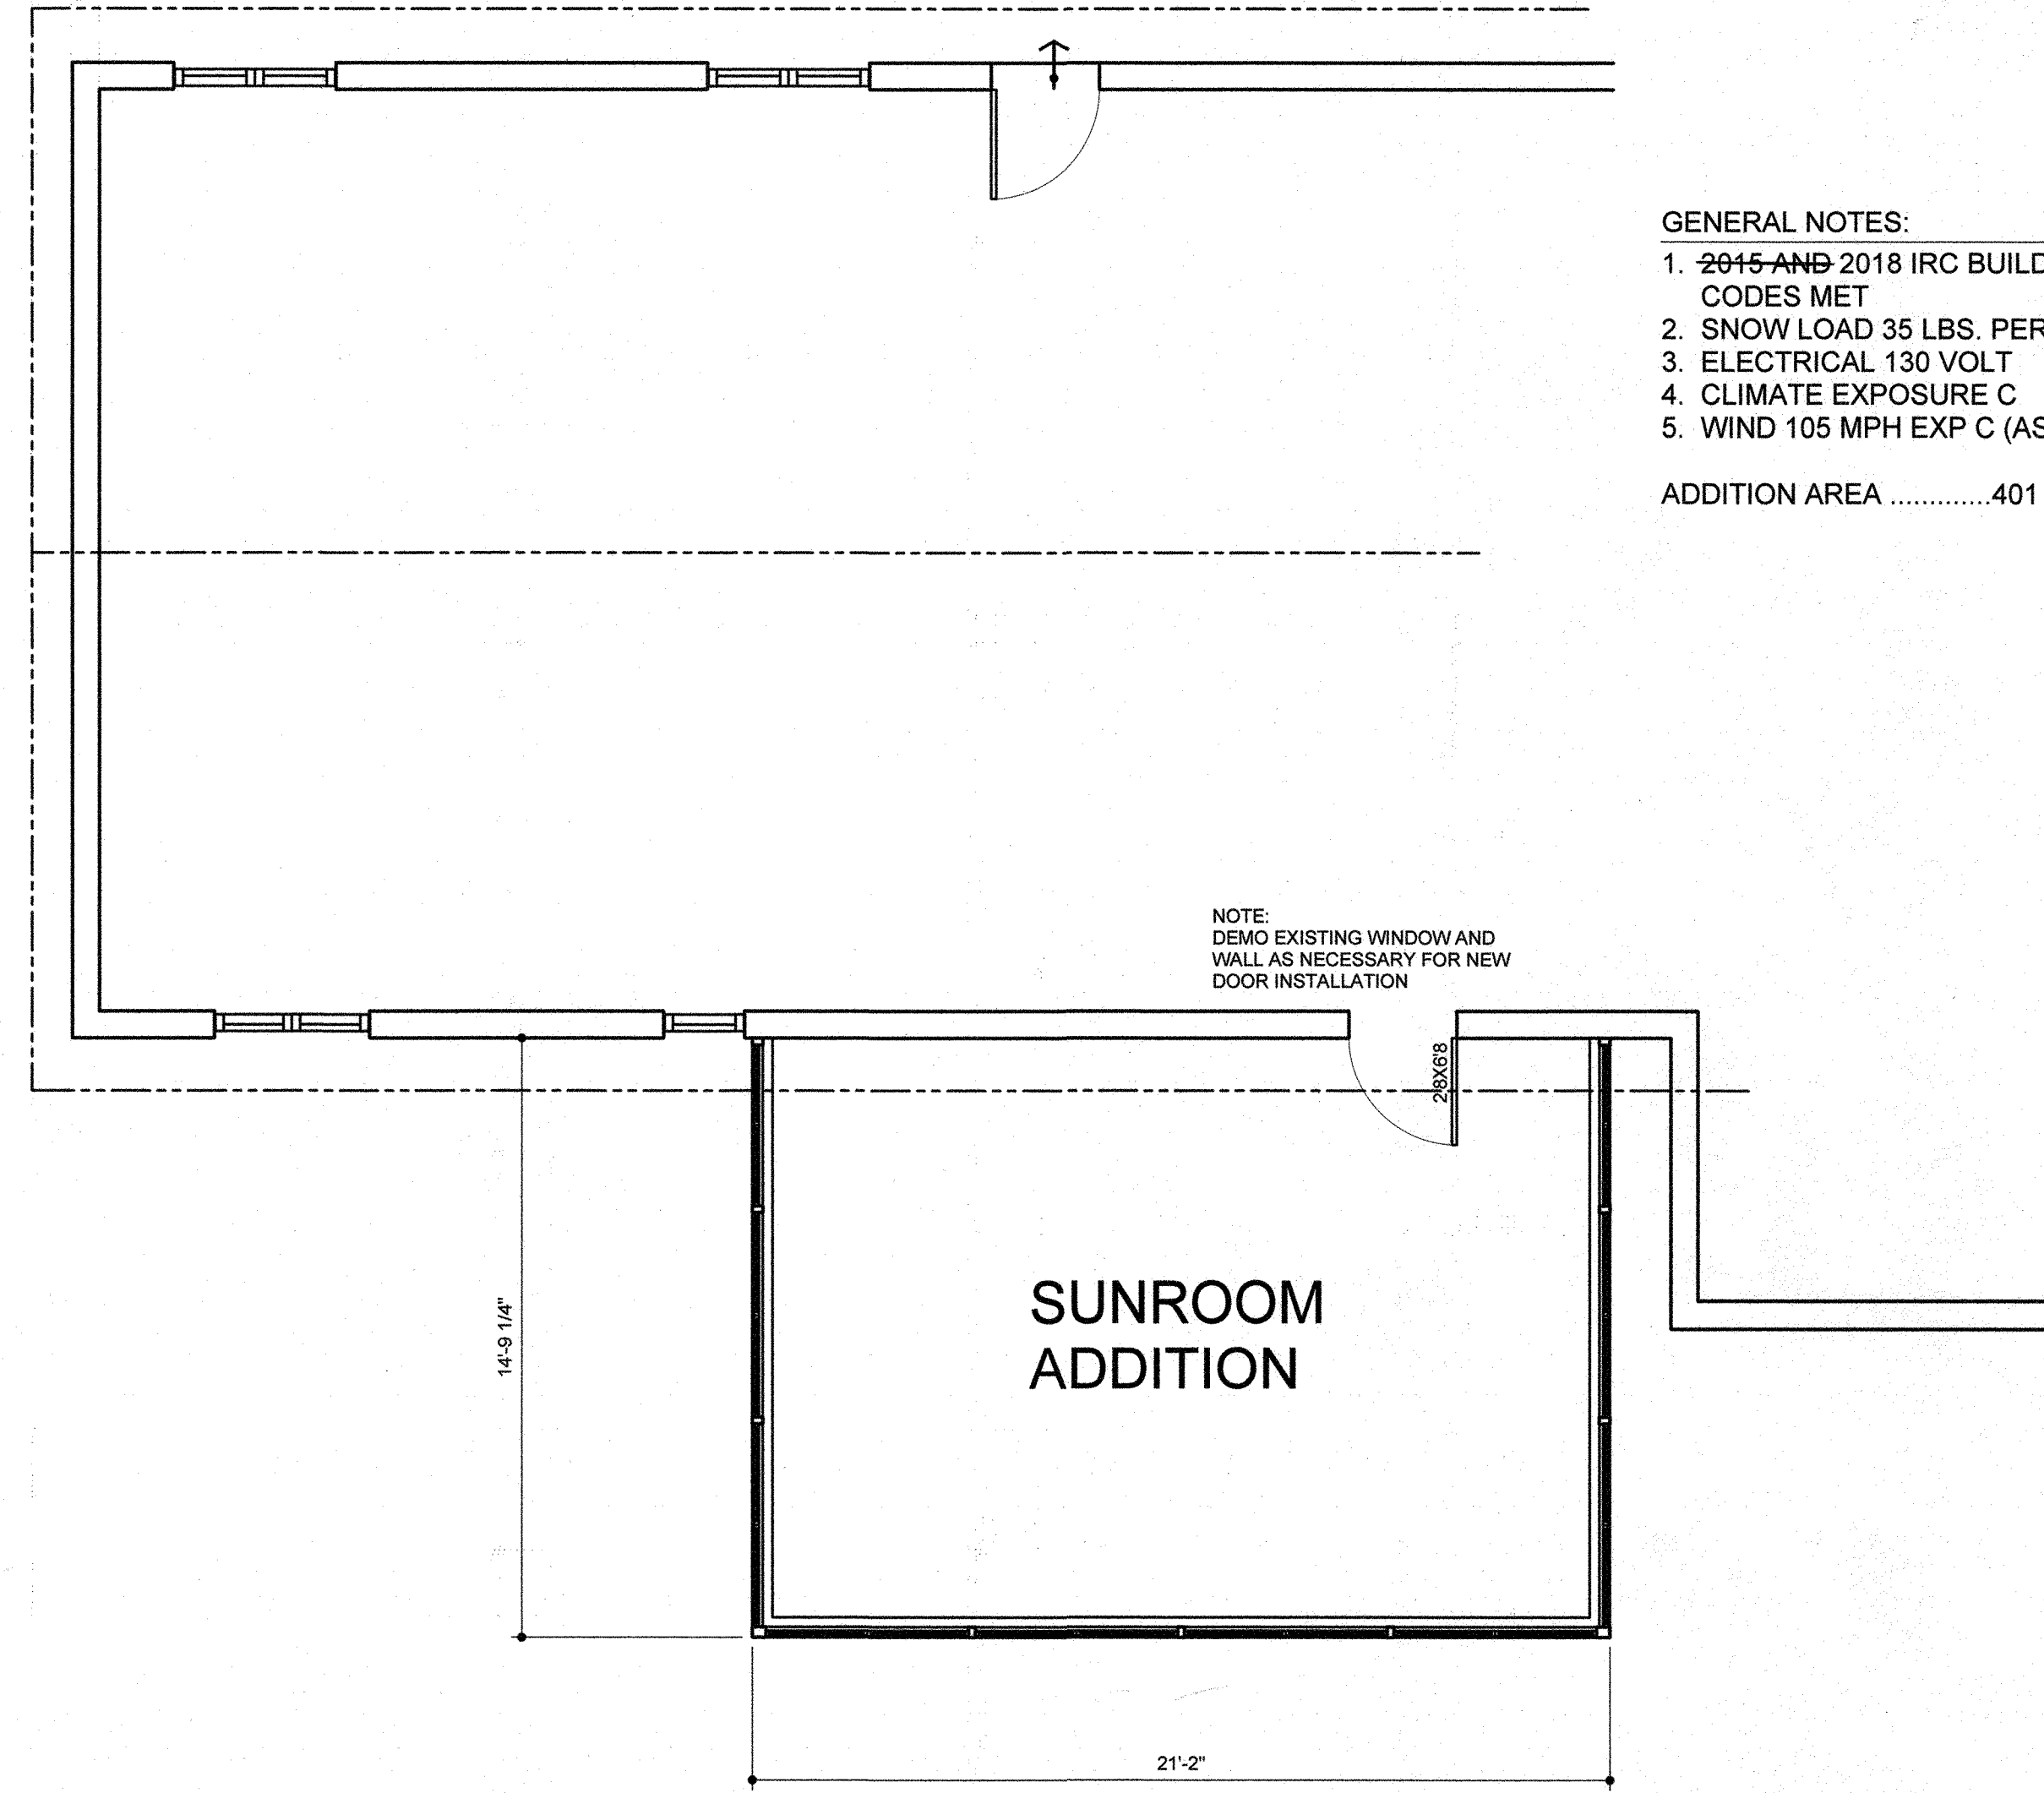

1 sunroom floor plan  
A2 scale 1/4" = 1' - 0"

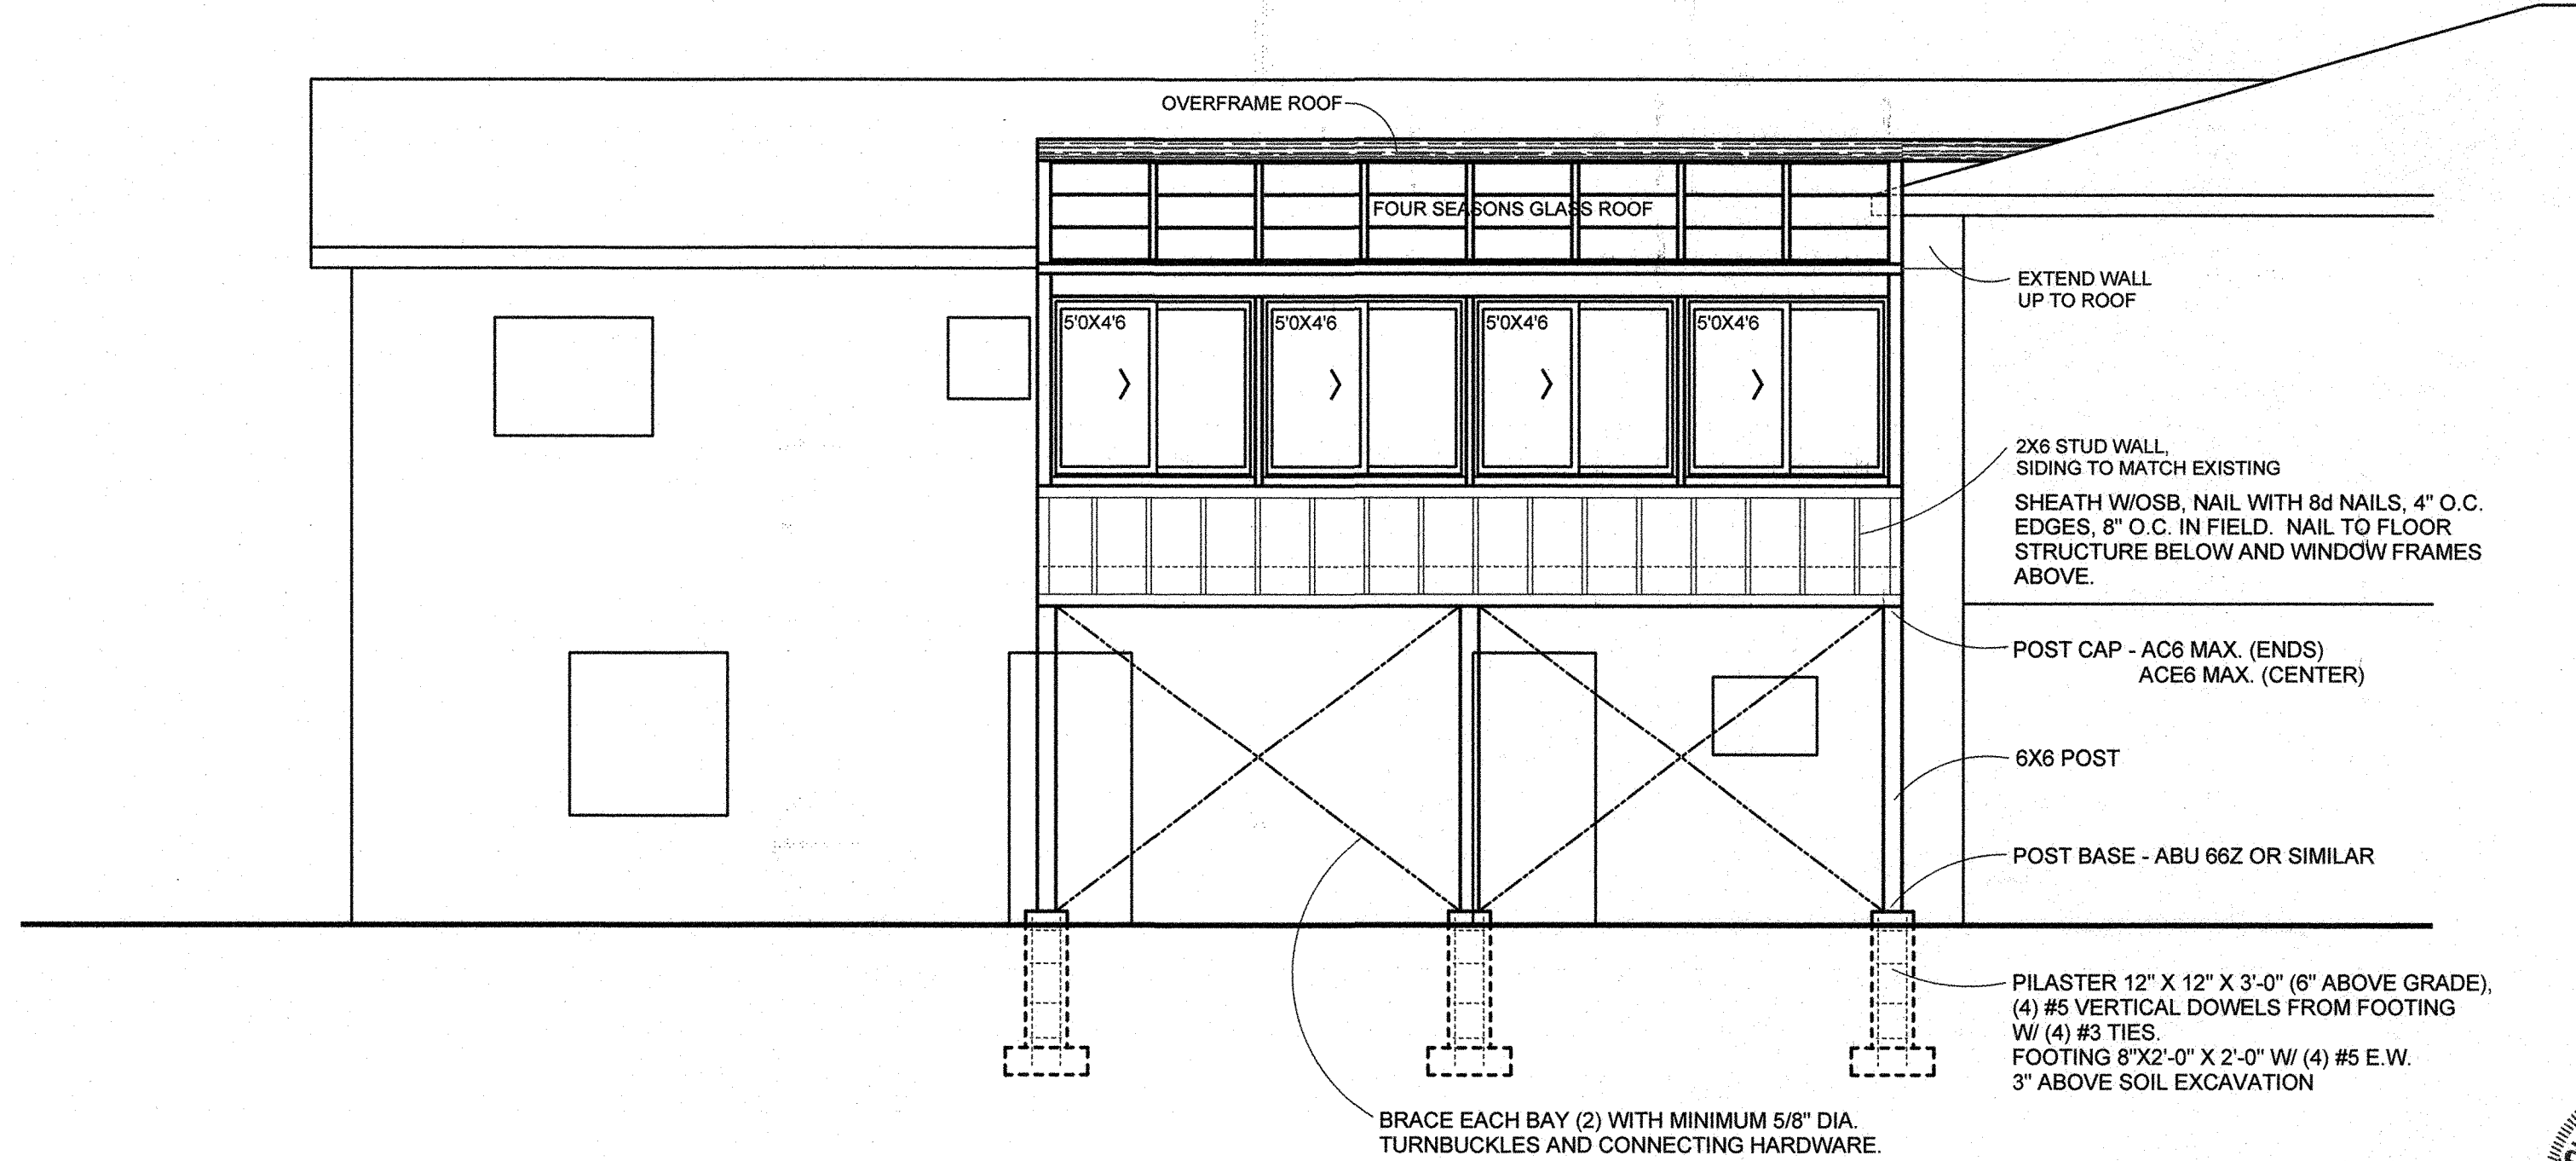

3 front elevation  
A2 scale 1/4" = 1' - 0"

GENERAL NOTES:  
1. ~~2015~~ ~~AND~~ 2018 IRC BUILDING CODES MET  
2. SNOW LOAD 35 LBS. PER SQ. FT.  
3. ELECTRICAL 130 VOLT  
4. CLIMATE EXPOSURE C  
5. WIND 105 MPH EXP C (ASD) - 135 MPH EXP C (UH)  
ADDITION AREA .....401 SQ. FT.

ROBERT C. WACKER  
A RESIDENTIAL DESIGN STUDIO  
5581 SPRUCE AVENUE  
CASTLE ROCK COLORADO 80104  
303.559.7580

COLORADO/JUNROOM  
and WINDOW DISTRIBUTORS  
641 SOUTH WYOMING STREET  
DENVER COLORADO 80225  
303.715.0777


VILLAGIO  
399 GILBERT STREET  
CASTLE ROCK COLORADO 80104

DATE 01/29/2021  
DRAWN BY RCW  
CHECKED BY  
JOB NO.


REVISIONS

A2




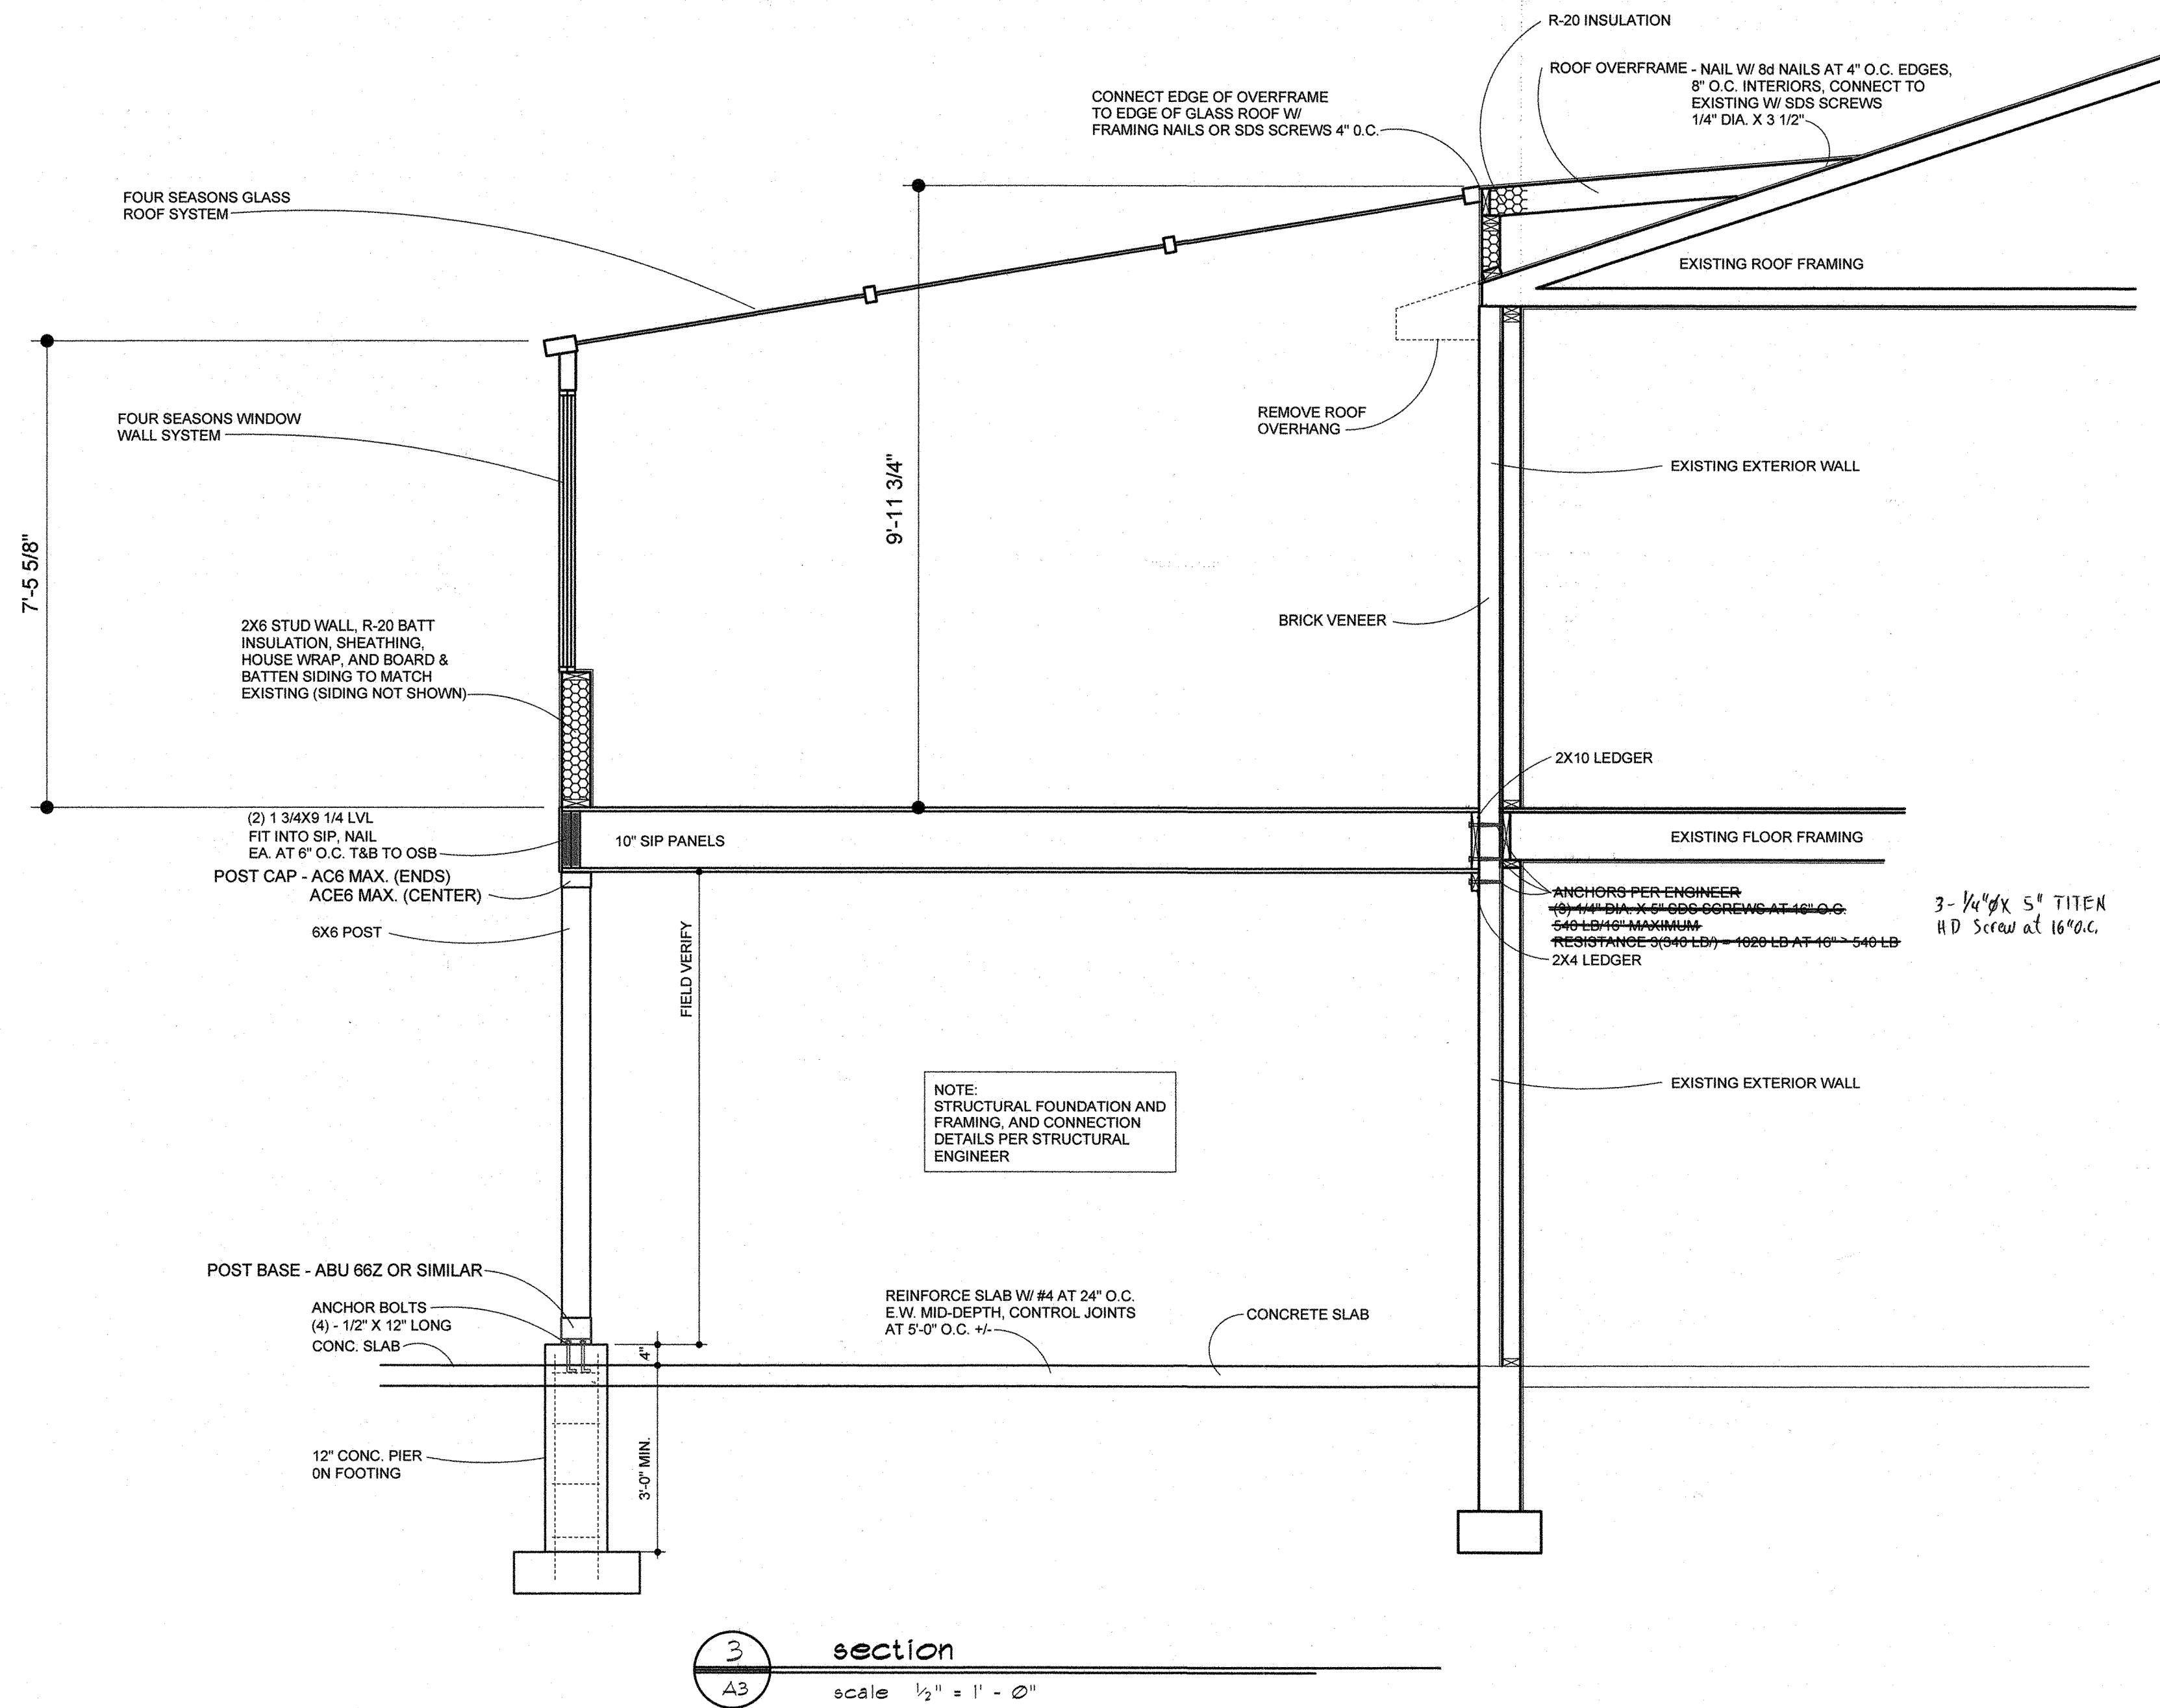

3 section  
scale 1/2" = 1' - 0"

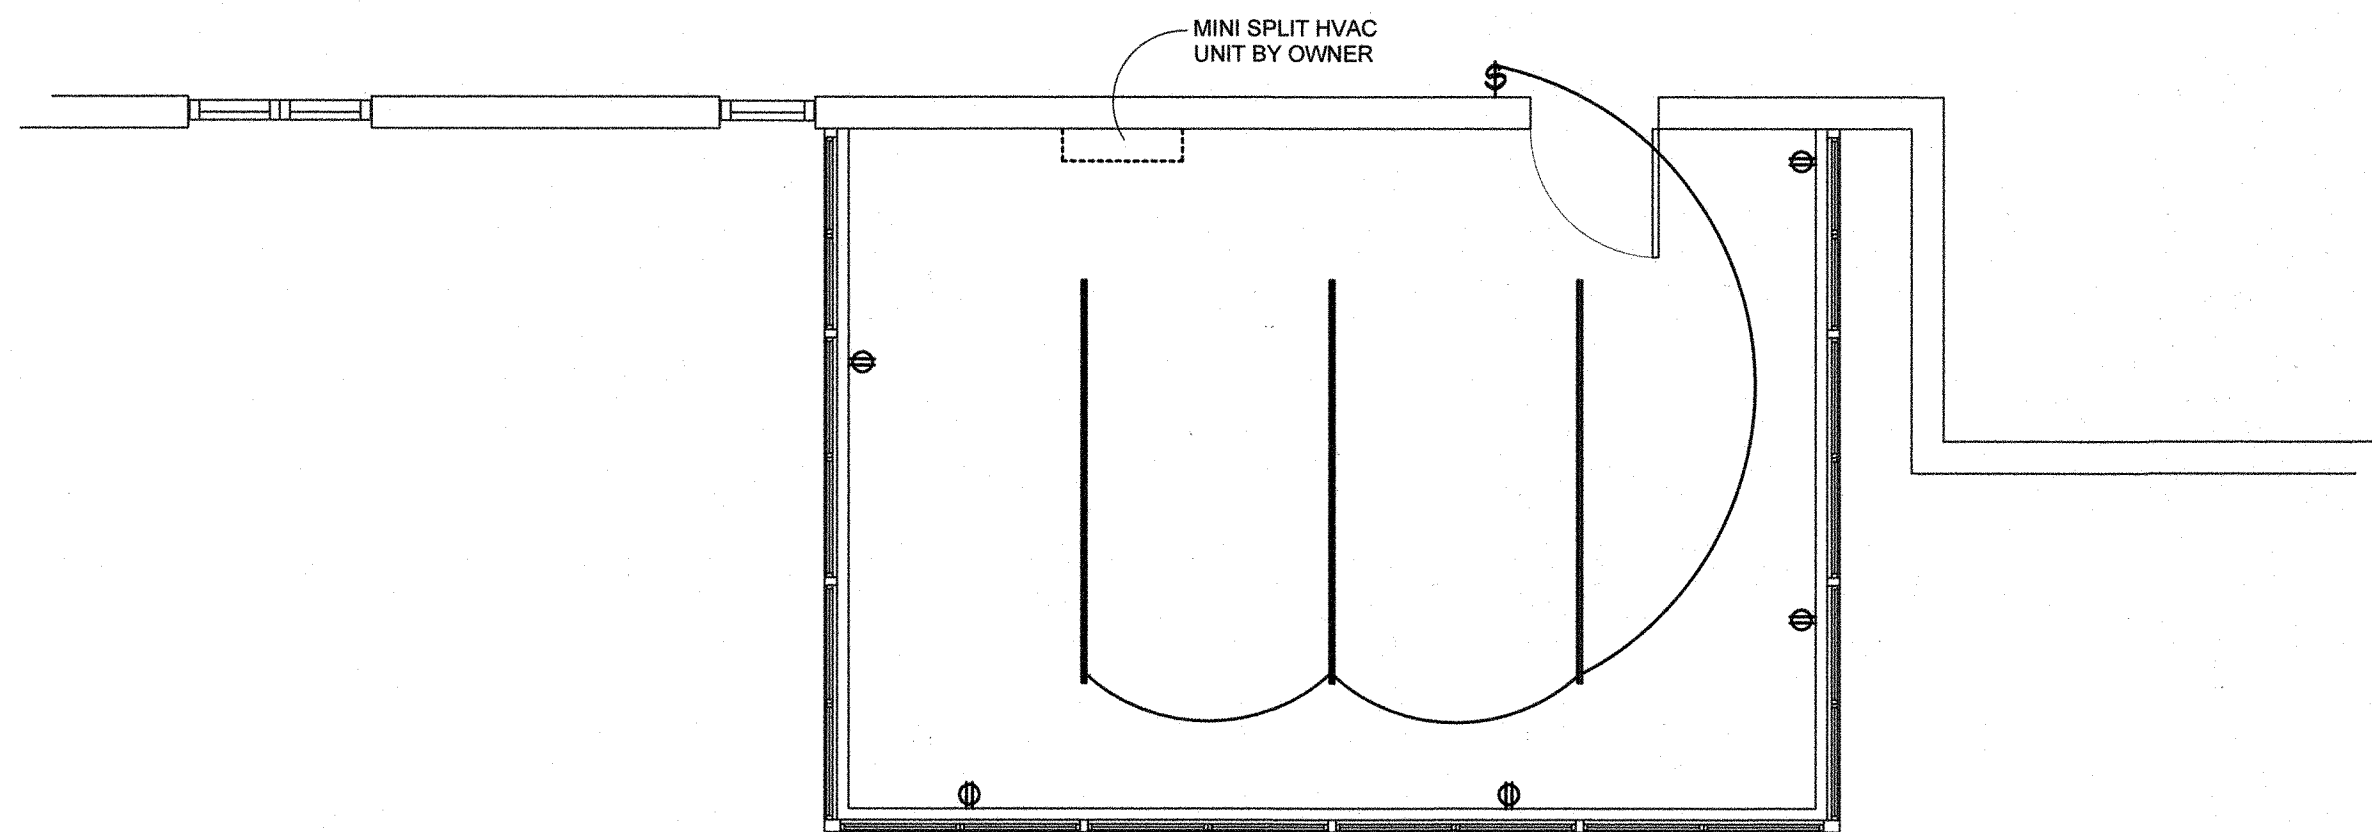

2 electrical plan  
scale 1/4" = 1' - 0"

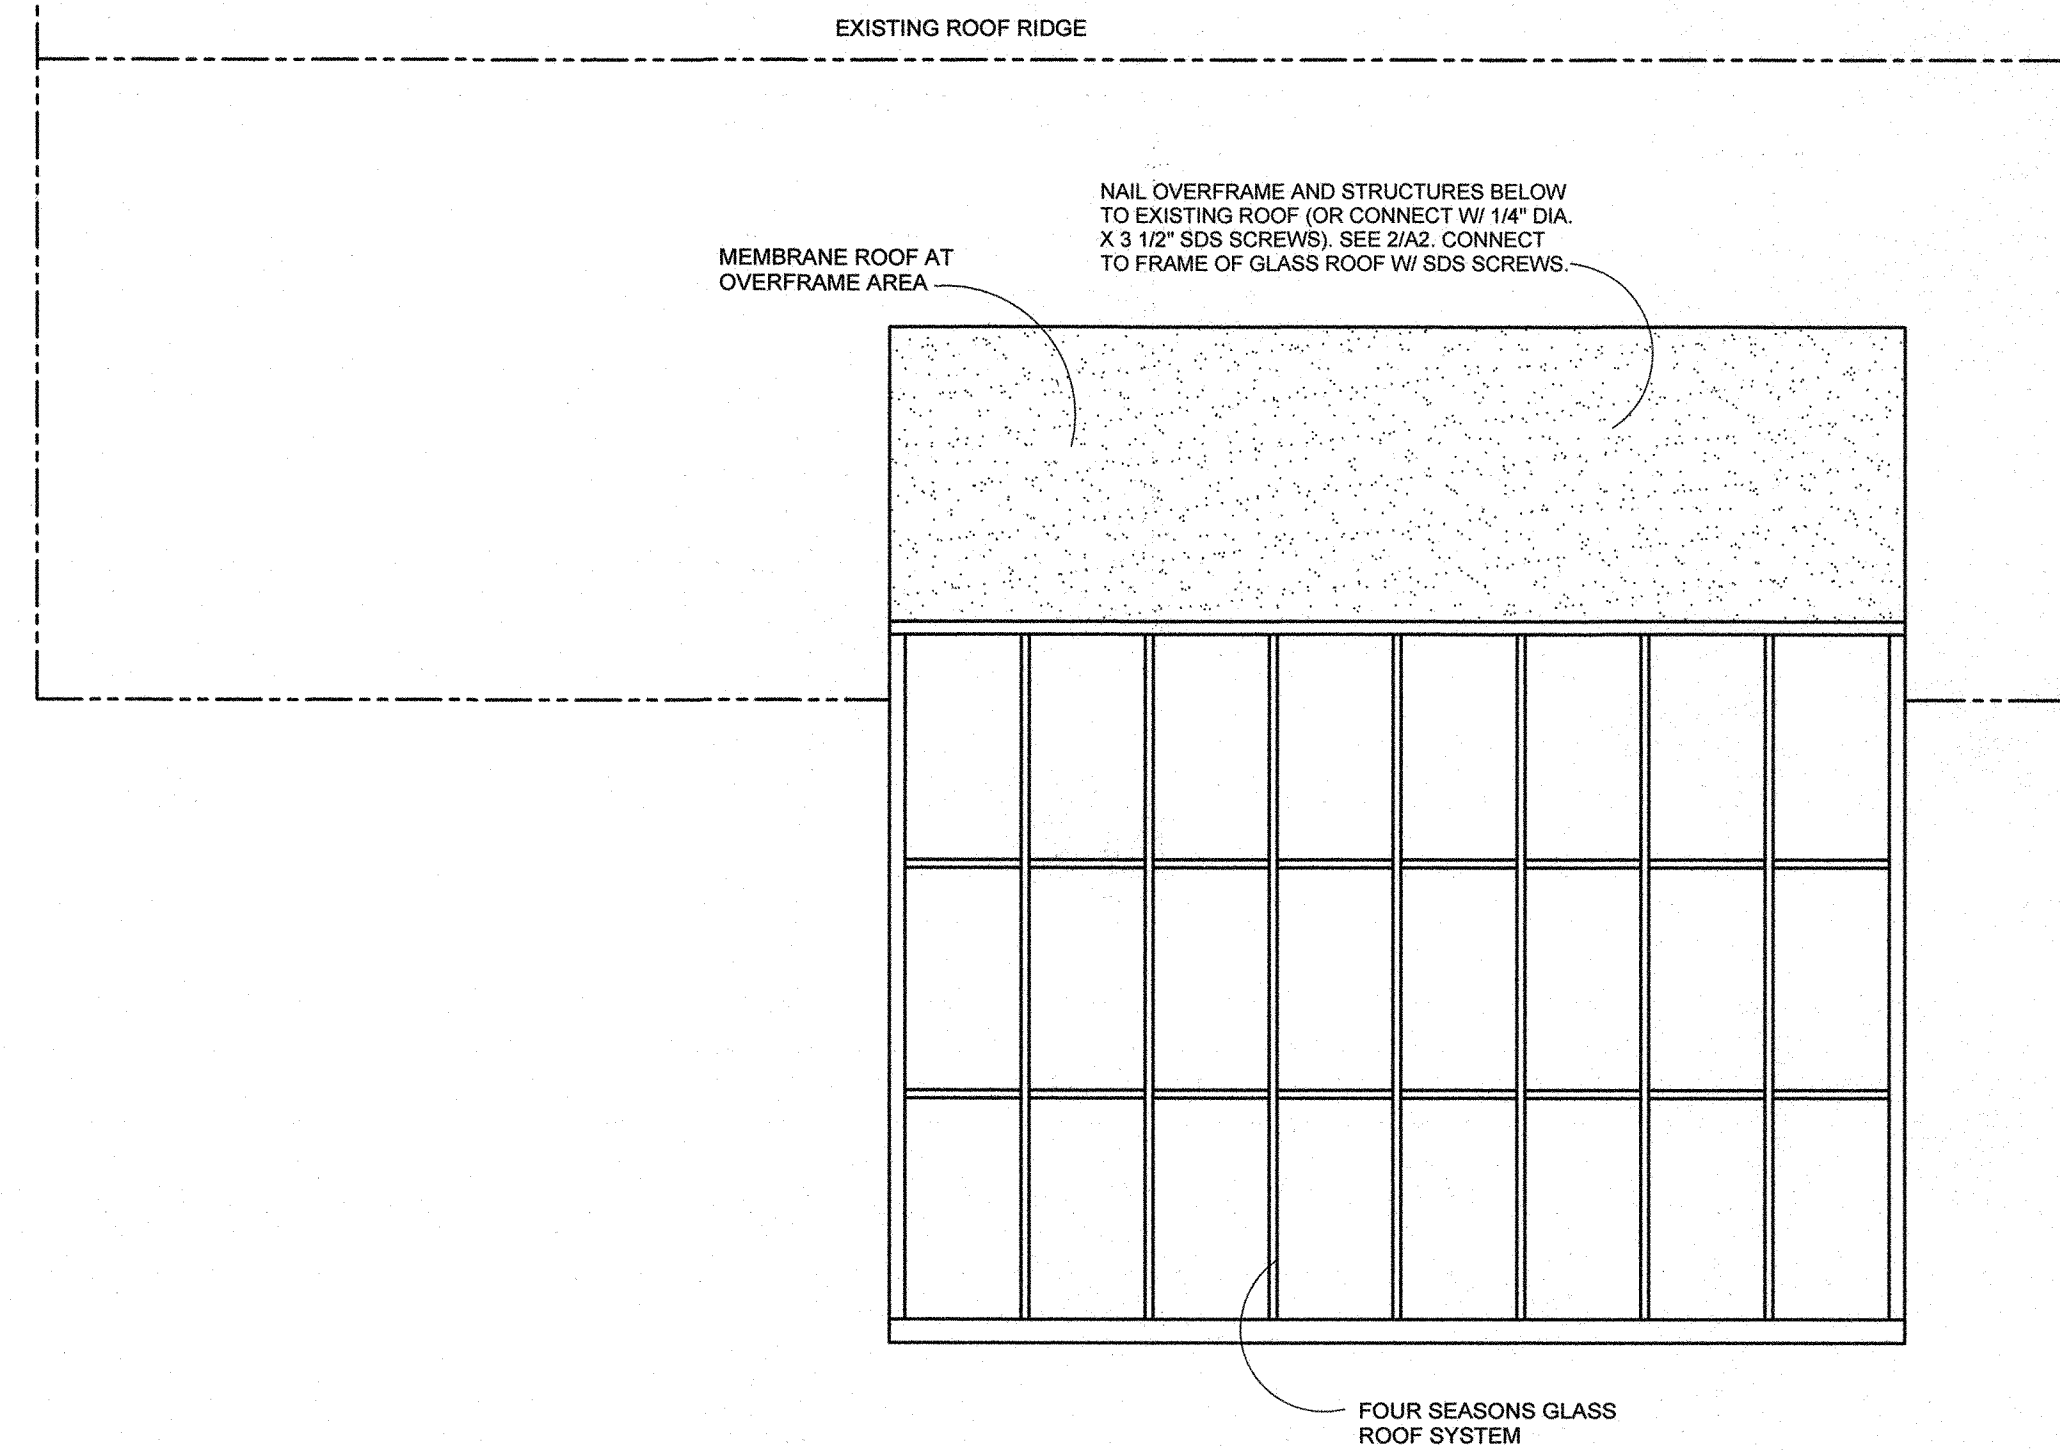

1 roof plan  
scale 1/4" = 1' - 0"

#### LIGHTING / ELECTRICAL LEGEND

- ⊕ duplex outlet
- ⊙ recessed downlight
- ⊙ recessed wallwasher - style per owner
- ⊙ fixture selection by owner
- ⊙ decorative wall light - interior or exterior
- ⊙ exhaust fan
- ⊙ 1" undercabinet light
- ⊙ smoke detector
- ⊙ ceiling fan
- ⊙ switch - one location
- ⊙ gas service - fireplace, appliances, hvac, etc.
- ⊙ track strip (size per owner)
- ⊙ verify location in field
- ⊙ combination smoke and carbon monoxide detector

NOTE:  
A MINIMUM OF 15 PERCENT OF LAMPS IN PERMANENTLY INSTALLED LIGHTING FIXTURES SHALL BE HIGH-EFFICACY LAMPS.



ROBERT C. WACKER  
A/R/C/D/T/AL/D/L/G/A /TUDIO  
5581 /PRUCE AVENUE  
CAYLE ROCK COLORADO 80104  
303.559.7580

COLORADO JOURNAL  
and WINDOW DISTRIBUTORS  
641 /OUTH LA /ON /TREET  
DENVER COLORADO 80225  
303.715.0777

VILLAGIO  
399 GILBERT STREET  
CASTLE ROCK COLORADO 80104

DATE 07/29/2021  
DRAWN BY RCW  
CHECKED BY  
JOB NO.

REVISIONS

A3